




- A0.0 PROJECT INFORMATION AND O.B.C. MATRIX**
- A1.1 EXISTING KEY PLANS, SITE MOBILIZATION PLAN, LEGEND AND NOTES**
- A2.1 PARTIAL GROUND FLOOR DEMOLITION PLAN, LEGEND AND NOTES**
- A2.2 PARTIAL PROPOSED GROUND FLOOR PLAN AND LEGEND**
- A2.3 PARTIAL ROOF PLAN, LEGEND AND NOTES**
- A3.1 PARTIAL DEMOLITION REFLECTED CEILING PLANS, LEGEND AND NOTES**
- A3.2 PARTIAL PROPOSED REFLECTED CEILING PLANS, LEGEND AND NOTES**
- A4.1 TYPICAL CLASSROOM INTERIOR ELEVATIONS AND PROPOSED EXTERIOR ELEVATIONS**
- A4.2 PROPOSED EXTERIOR ELEVATIONS AND TYPICAL INTERIOR ELEVATIONS**
- A5.1 WALL SECTIONS**
- A5.2 DETAILS**

S1	PART GROUND FLOOR PLAN
S2	PART ROOF FRAMING PLAN
S3	UNITS AND OPENING FRAMING DETAILS IN EXISTING WOOD DECK ROOF
S4	UNITS AND OPENING FRAMING DETAILS IN EXISTING STEEL DECK ROOF
S5	GENERAL NOTES


- M101 BUILDING PLAN, SCHEDULES & GENERAL NOTES**
- M102 SCHEDULES**
- M201 GROUND & 2ND FLOOR BLOCK A PART PLANS HVAC DEMOLITION**
- M202 GROUND FLOOR BLOCK B PART PLAN HVAC DEMOLITION**
- M301 GROUND & 2ND FLOOR BLOCK A PART PLANS HVAC RENOVATION**
- M302 GROUND FLOOR BLOCK B PART PLAN HVAC RENOVATION**
- M401 ROOF BLOCK A PART PLAN HEATING & VENTILATION RENOVATION**
- M402 ROOF BLOCK B PART PLAN HEATING & VENTILATION RENOVATION**
- M501 GROUND & 2ND FLOOR FIRE SUPPRESSION PLAN**
- M601 BOILER ROOM DEMOLITION & RENOVATION**
- M701 MECHANICAL DETAILS & SECTIONS**


[illegible]
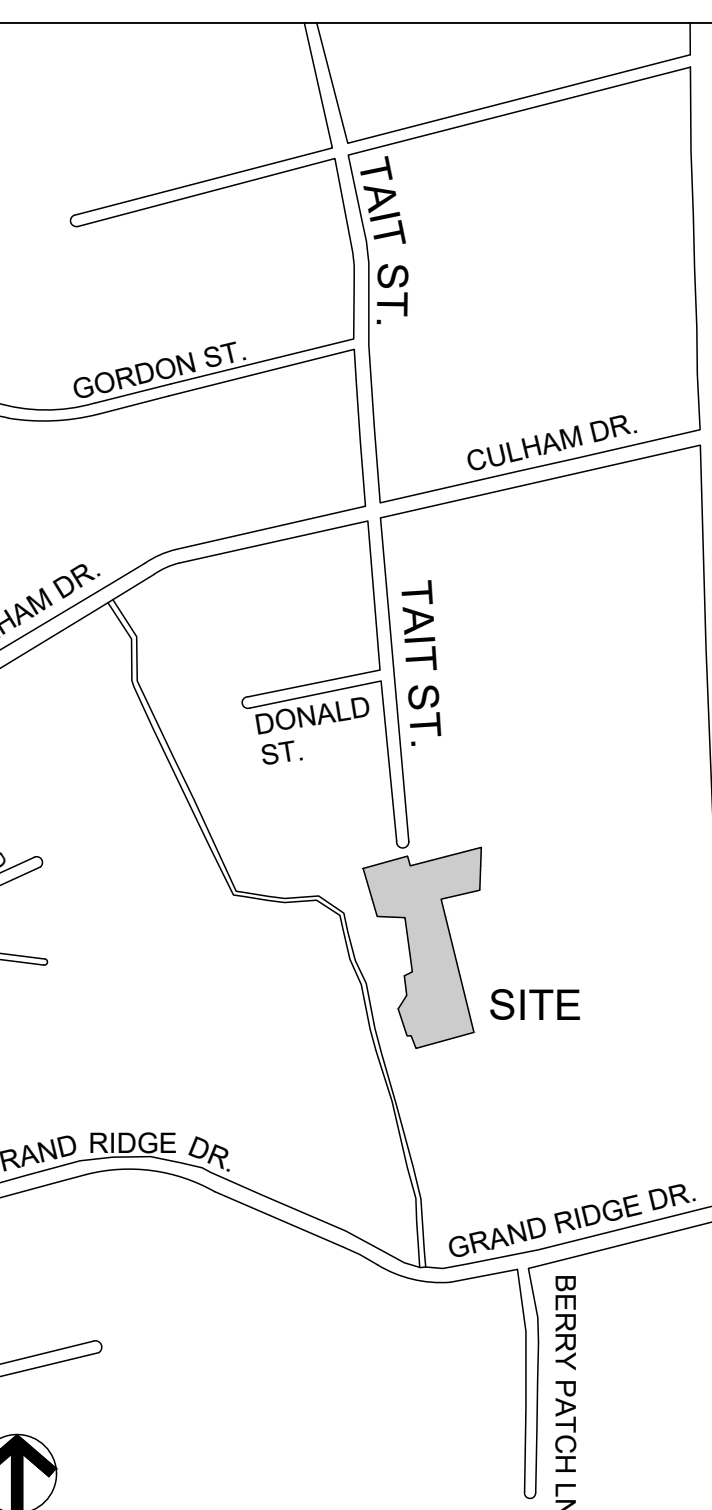
<b>PROJECT INFORMATION</b>	
PROJECT TITLE: WRDSB TAIT STREET PUBLIC SCHOOL HVAC RENOVATIONS TENDER No. 7198-RW-22	
PROJECT ADDRESS: 184 TAIT STREET, CAMBRIDGE, ONTARIO N1S 3G3	
OWNER: WATERLOO REGION DISTRICT SCHOOL BOARD	
OWNER'S CONTACT INFORMATION: 51 ARDELT AVENUE, KITCHENER, ON N2C 2R5	
CONSULTANT: ward99 architects inc.	
CONSULTANT 'S CONTACT INFORMATION: 7500 HIGHWAY 27 UNIT 27B VAUGHAN ON L4H 0J2 TEL: 416-613-5880 EMAIL: INFO@WARD99ARCHITECTS.COM	
<b>KEY PLAN</b>	
	
CLOSEST MAIN INTERSECTION: TAIT ST. AND DONALD ST.	

ONTARIO ASSOCIATION  
OF  
ARCHITECTS  
*Tina Ranieri D'Ovidio*  
TINA RANIERI-D'OVIDIO  
LICENCE  
5980



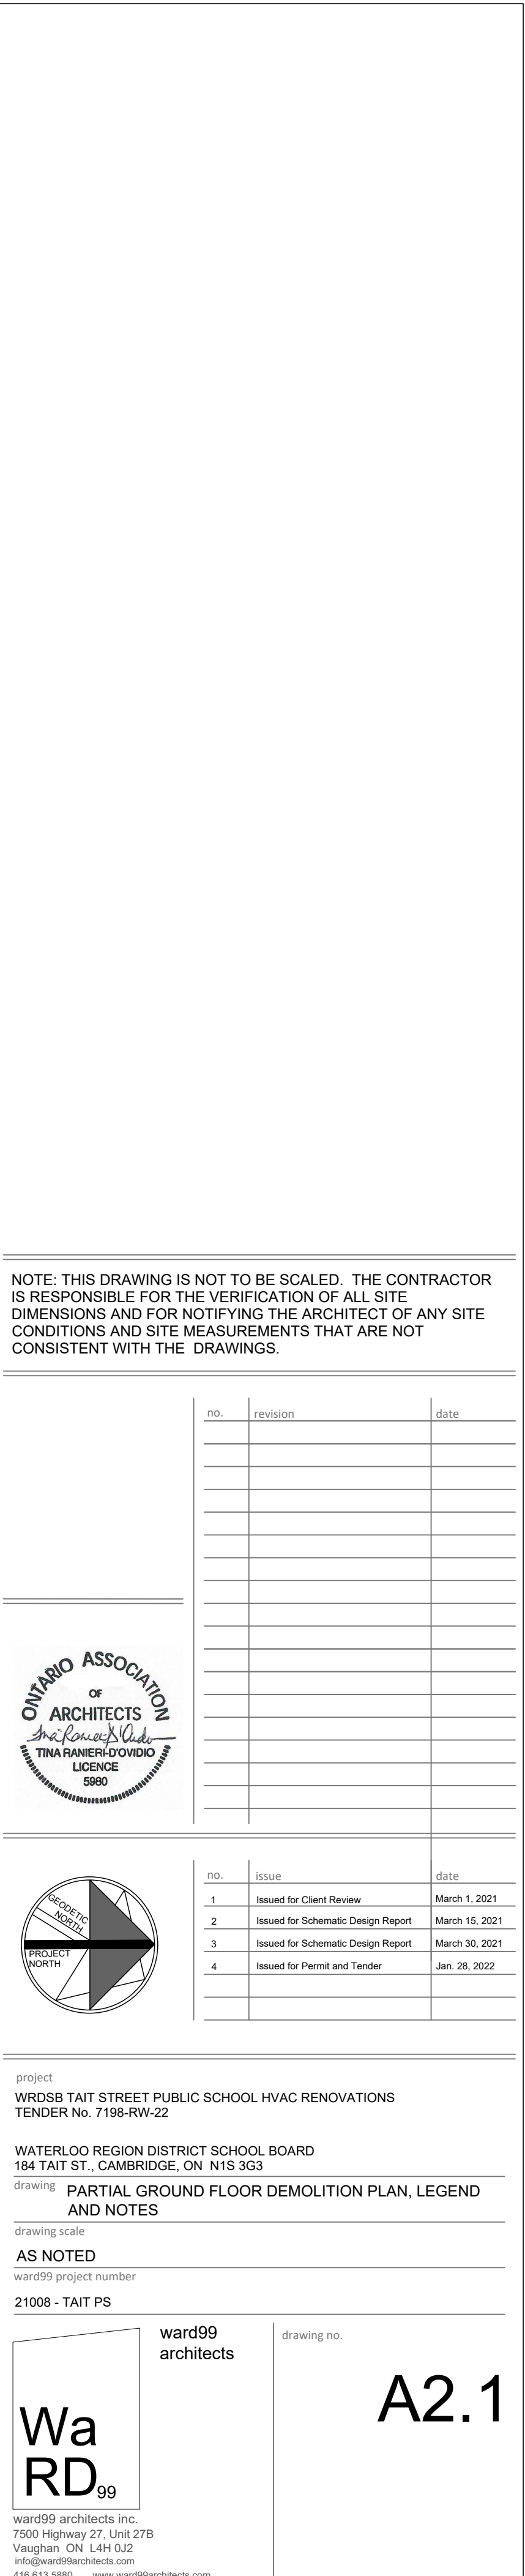

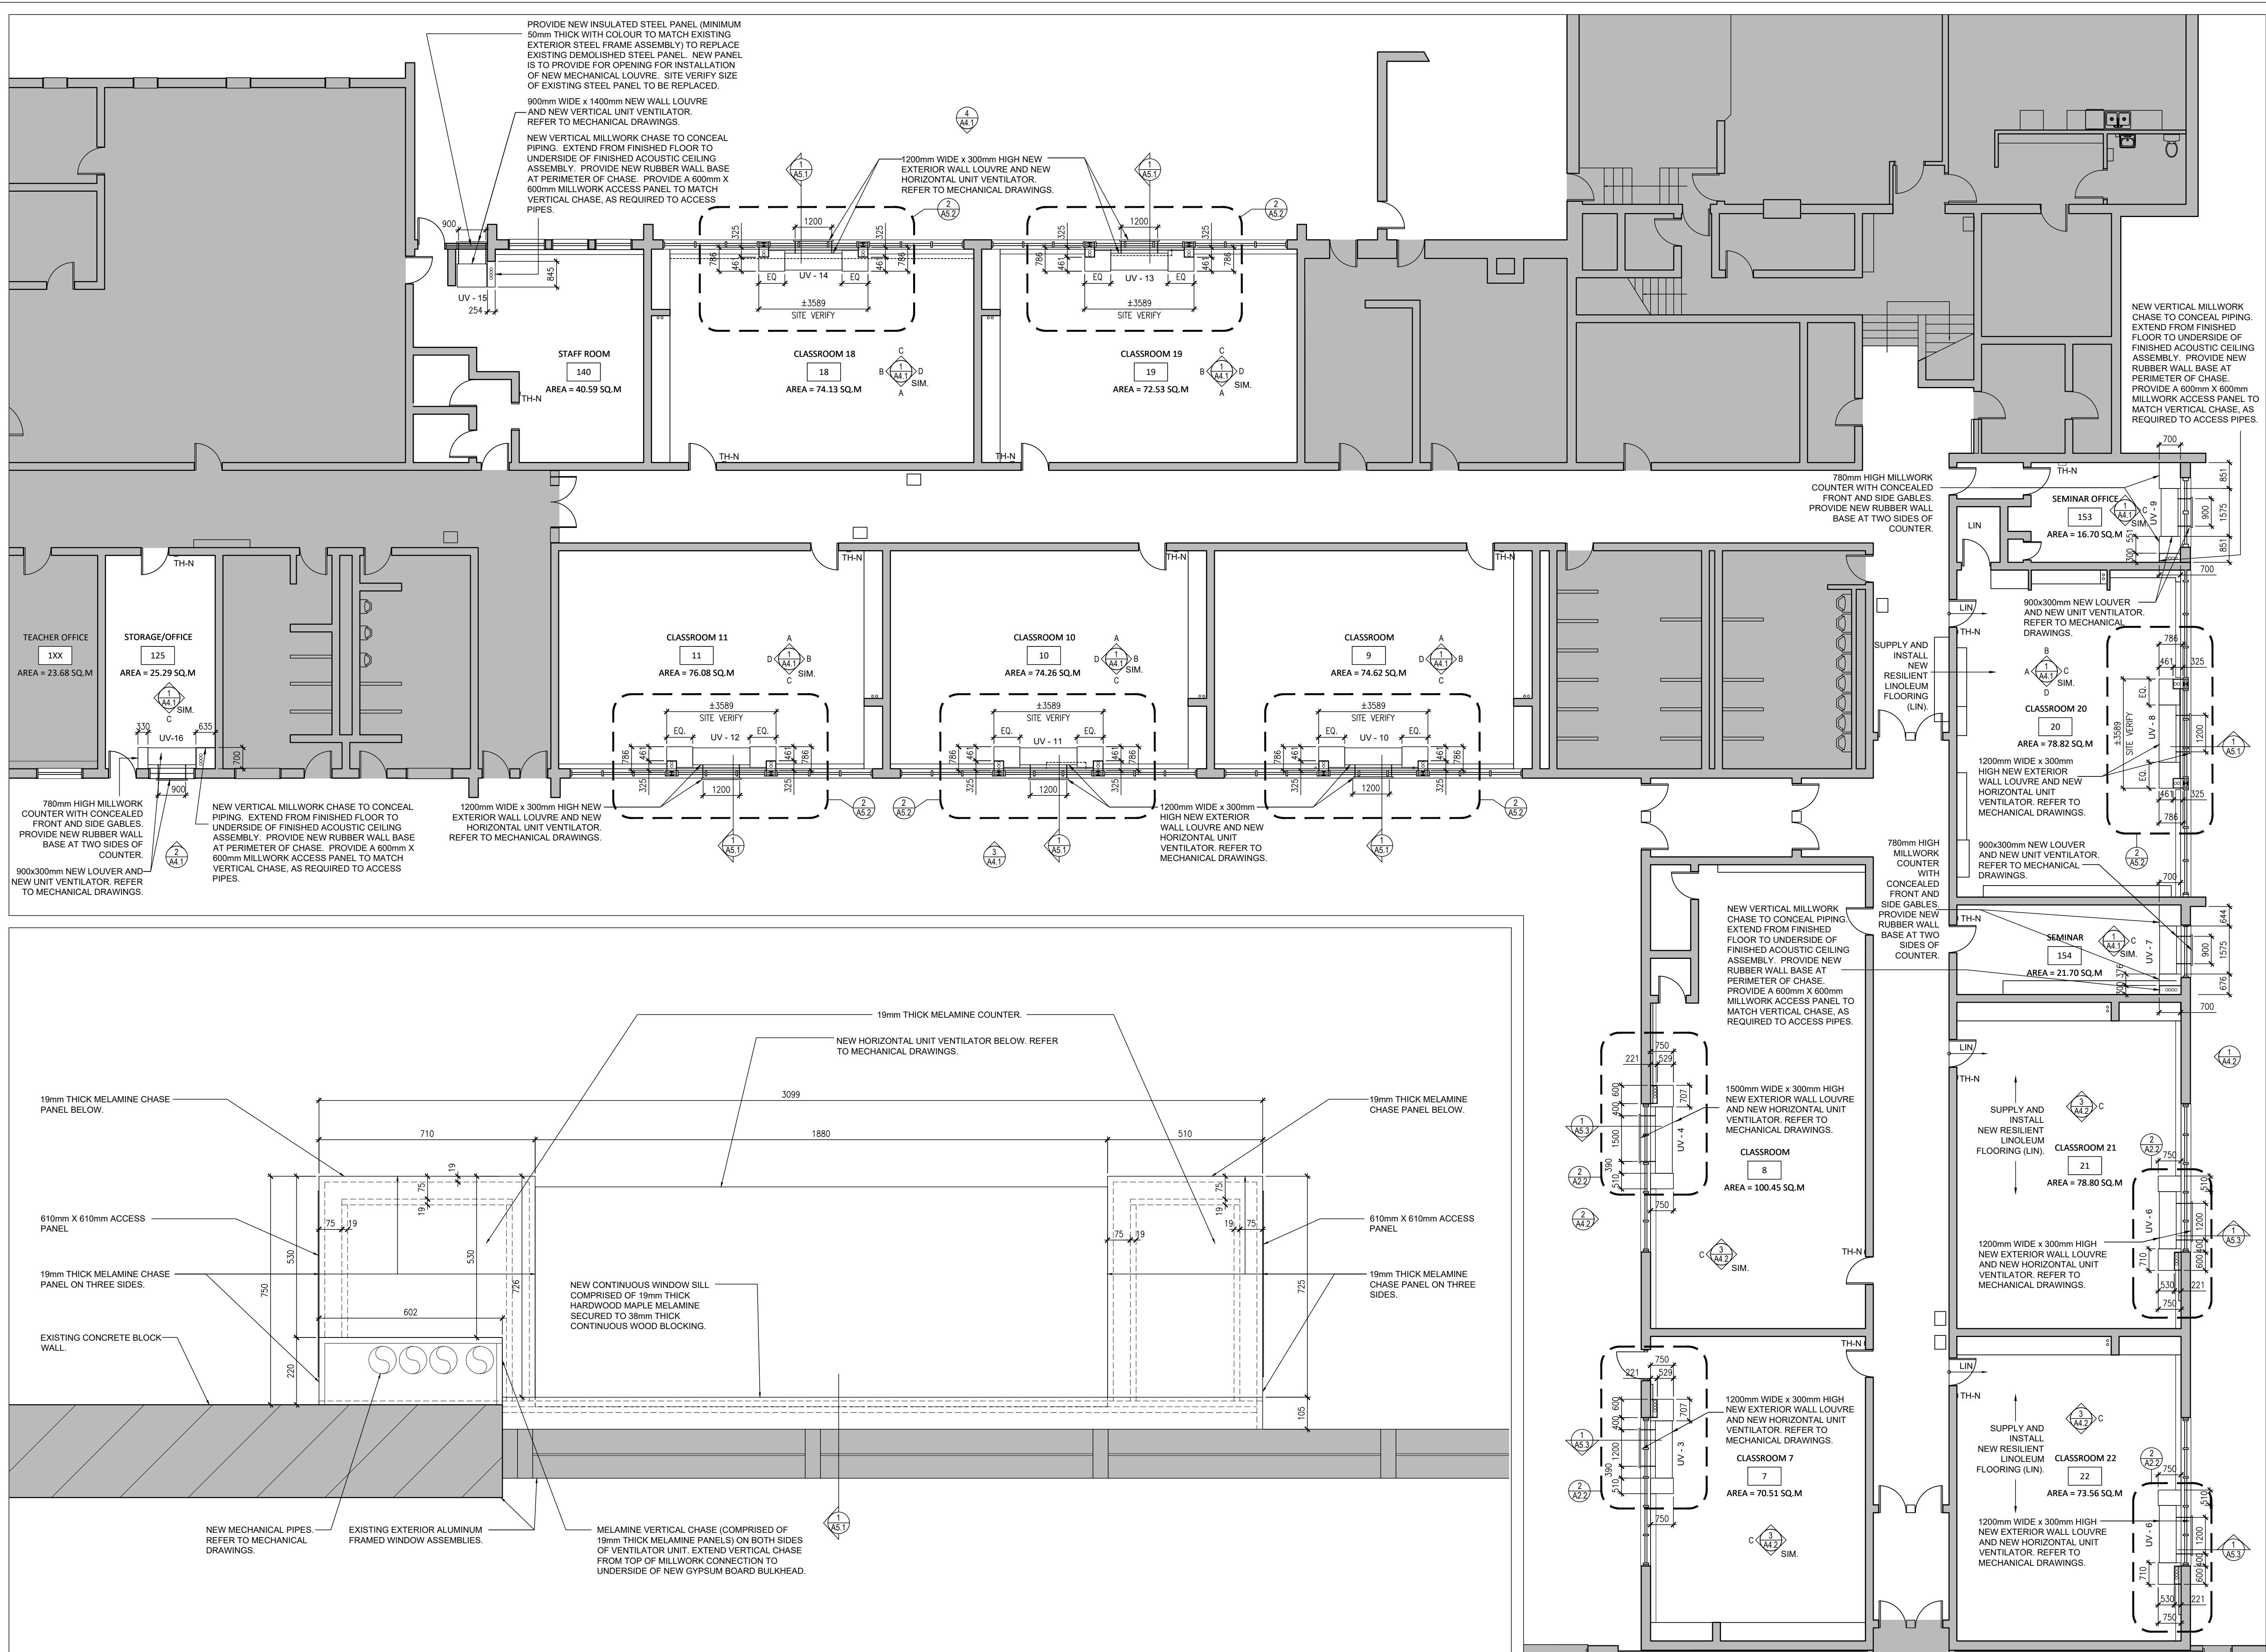

GENERAL FLOOR PLAN NOTES

1. PROPOSED DRAWINGS ON A2.2 AND A2.3 SHALL BE READ IN CONJUNCTION WITH ALL DEMOLITION DRAWINGS AND ALL OTHER ARCHITECTURAL, STRUCTURAL, MECHANICAL AND ELECTRICAL DRAWINGS FOR ADDITIONAL INFORMATION, DETAILS, NOTES AND DIMENSIONS.

2. 

1

AX

DETAIL TAG: DETAIL NUMBER/DRAWING NUMBER

3. 

A

1

B

C

ELEVATION TAG: ELEVATION DETAIL NUMBER/DRAWING NUMBER

4. 

1

AX

SECTION TAG: SECTION DETAIL NUMBER/DRAWING NUMBER

5. 

ROOM NAME 1

ROOM NAME 1

B101

A= - m2

ROOM TITLE

ROOM NAME

ROOM NUMBER

ROOM AREA

6. PROVIDE PAINTING OF ALL NEW WALLS, GYPSUM BOARD FINISHED CEILINGS, STEEL DOORS AND FRAMES AND RADIATOR COVERS IN ALL ROOMS: 125, 140, 15, 19, 11, 10, 8, 193, 20, 154, 21, 22, 8 AND 9 AT ALL GYPSUM BOARD FINISHED CEILINGS IN THE GIRLS AND BOYS WASHROOMS AND IN CORRIDORS WHERE WORK IS OCCURRING AND IN OFFICES 201 AND 202 LOCATED ON THE SECOND FLOOR. REFER ALSO TO DEMOLITION NOTE 11 ON ARCHITECTURAL DRAWING A2.1.

7. LIN = SUPPLY AND INSTALL NEW LINOLEUM FLOORING AND NEW RUBBER WALL BASE.

NOTE: THIS DRAWING IS NOT TO BE SCALED. THE CONTRACTOR IS RESPONSIBLE FOR THE VERIFICATION OF ALL SITE DIMENSIONS AND FOR NOTIFYING THE ARCHITECT OF ANY SITE CONDITIONS AND SITE MEASUREMENTS THAT ARE NOT CONSISTENT WITH THE DRAWINGS.

no.

revision

date

1

1

2

1

3

1

4

1

no.

issue

date

1

Issued for Client Review

March 1, 2021

2

Issued for Schematic Design Report

March 15, 2021

3

Issued for Schematic Design Report

March 30, 2021

4

Issued for Permit and Tender

Jan. 28, 2022

ONTARIO ASSOCIATION OF ARCHITECTS

*the architects*

TINA RANIERI-D'AMICO

LICENCE 6960

PROJECT NORTH

project

WRDSB TAIT STREET PUBLIC SCHOOL HVAC RENOVATIONS

TENDER No. 7198-RW-22

WATERLOO REGION DISTRICT SCHOOL BOARD

184 TAIT ST., CAMBRIDGE, ON N1S 3G3

drawing

PARTIAL PROPOSED GROUND FLOOR PLAN AND LEGEND

drawing scale

AS NOTED

ward99 project number

21008 - TAIT PS

ward99 architects

architects

drawing no.

A2.2

ward99 architects inc.

7550 Highway 27, Unit 27B

Vaughan ON L4H 0J2

info@ward99architects.com

 
 
416 613 5860

www.ward99architects.com










no.	issue	date
1	Issued for Client Review	March 1, 2021
2	Issued for Schematic Design Report	March 15, 2021
3	Issued for Schematic Design Report	March 30, 2021
4	Issued for Permit and Tender	Jan. 28, 2022

416 613 5890 [www.wardwardward.com](http://www.wardwardward.com)

drawing no.

416 613 5890 [www.wardwardward.com](http://www.wardwardward.com)

## A4.1

 

no.	issue	date
1	Issued for Client Review	March 1, 2021
2	Issued for Schematic Design Report	March 15, 2021
3	Issued for Schematic Design Report	March 30, 2021
4	Issued for Permit and Tender	Jan. 28, 2022


ward99  
architects

drawing no.


A4.2

Ward99 architects inc.  
7550 Highway 27, Unit 27B  
Vaughan, ON L4H 0J2  
info@ward99architects.com  
416-813-5880      www.ward99architects.com


## A4.2

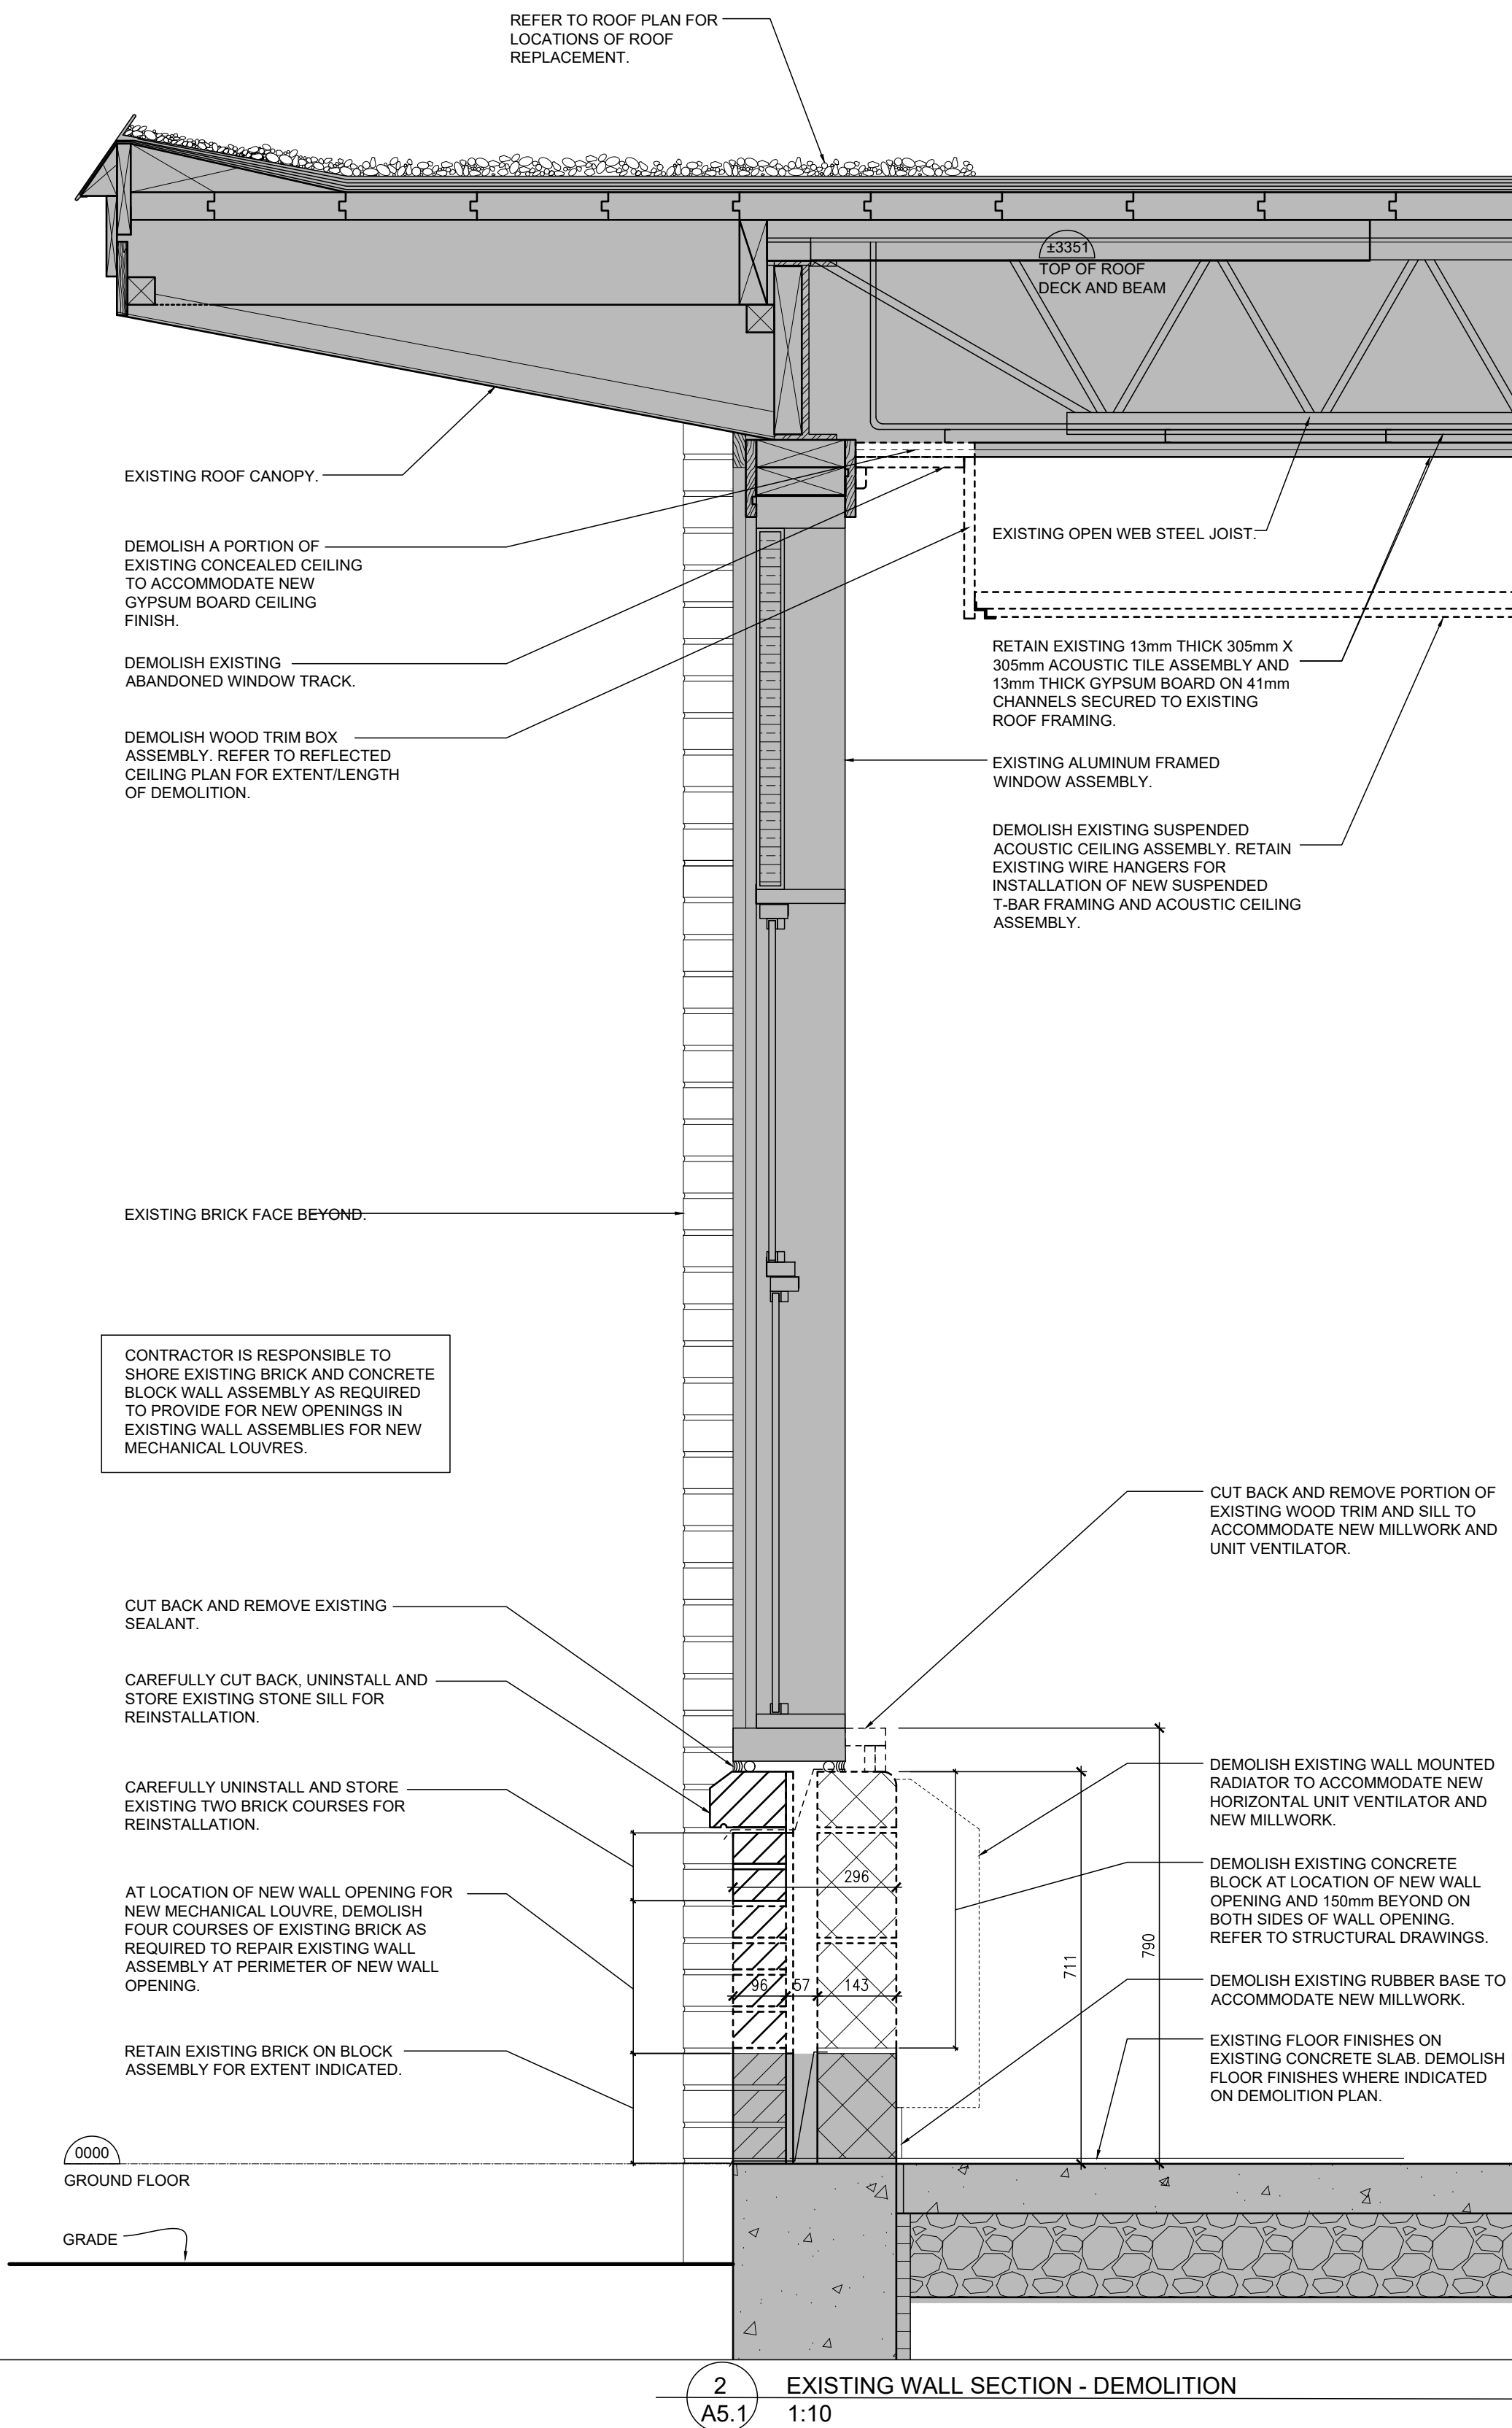

2  
A5.1  
EXISTING WALL SECTION - DEMOLITION  
1:10

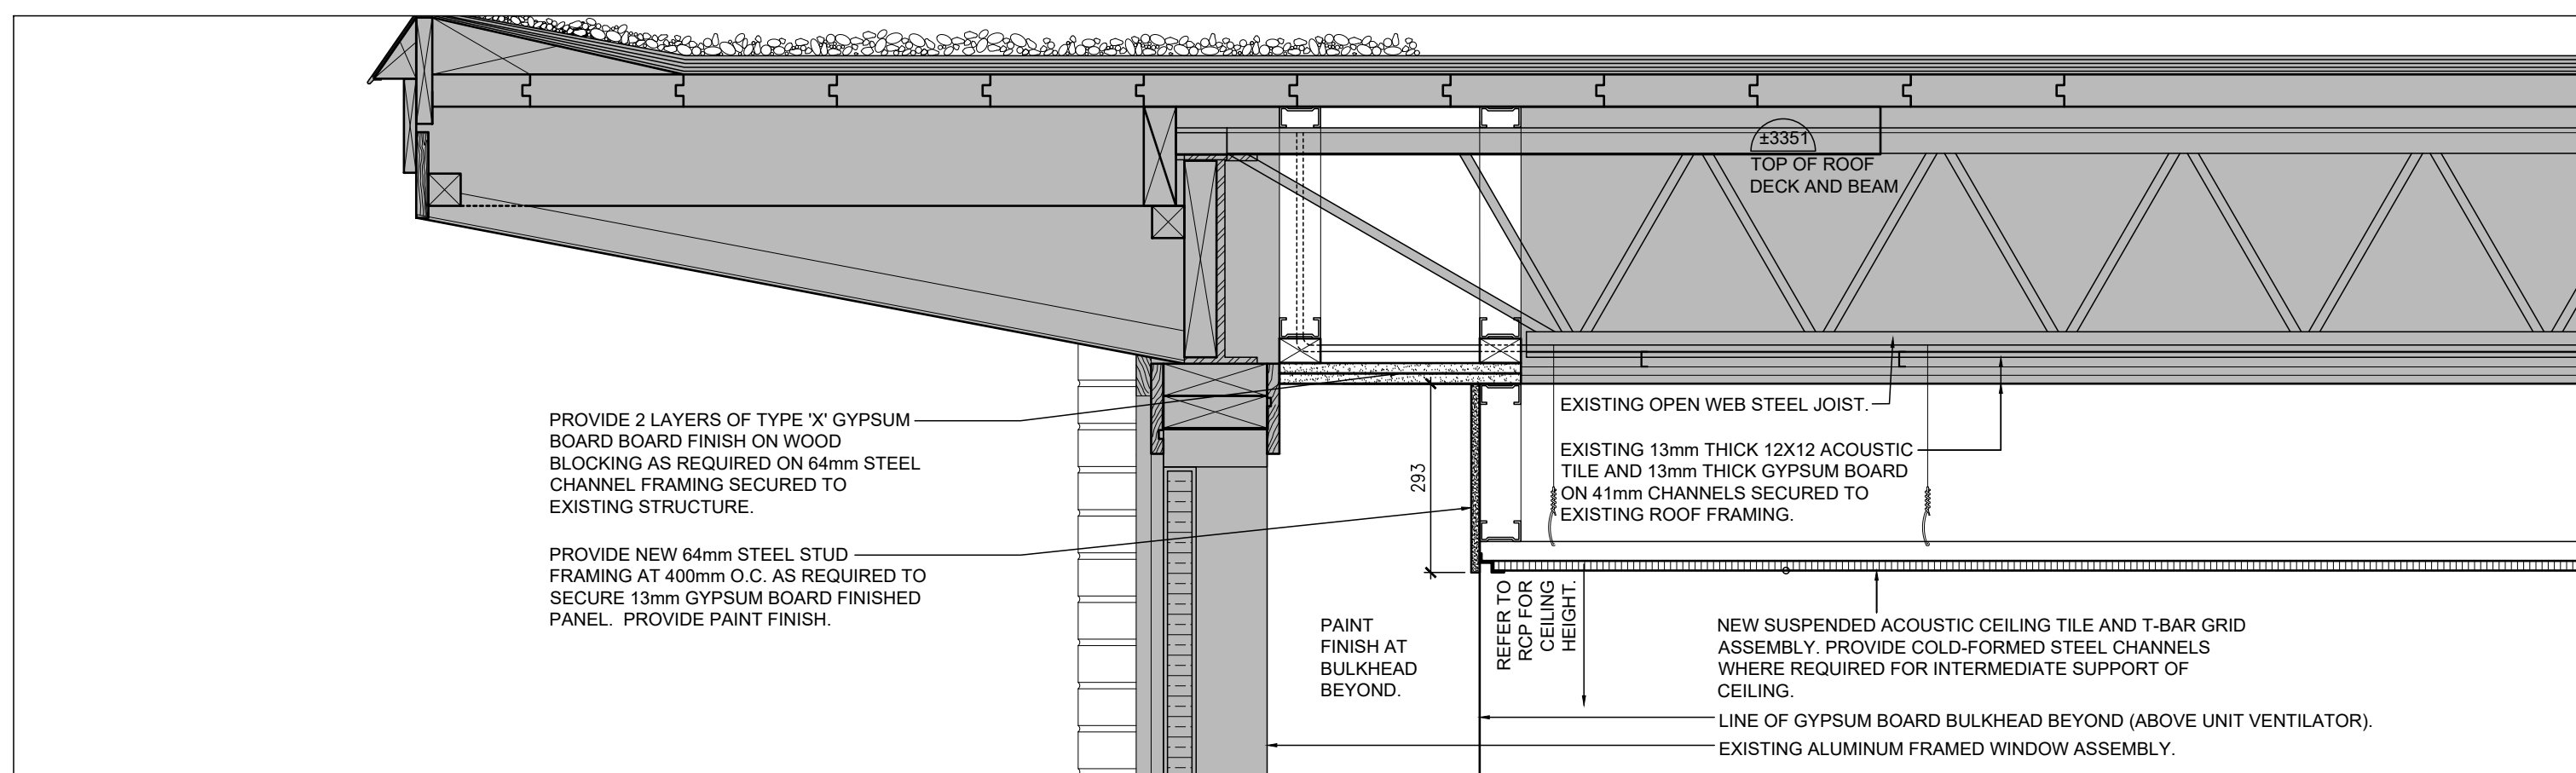

3  
A5.1  
PROPOSED CEILING DETAIL  
1:10

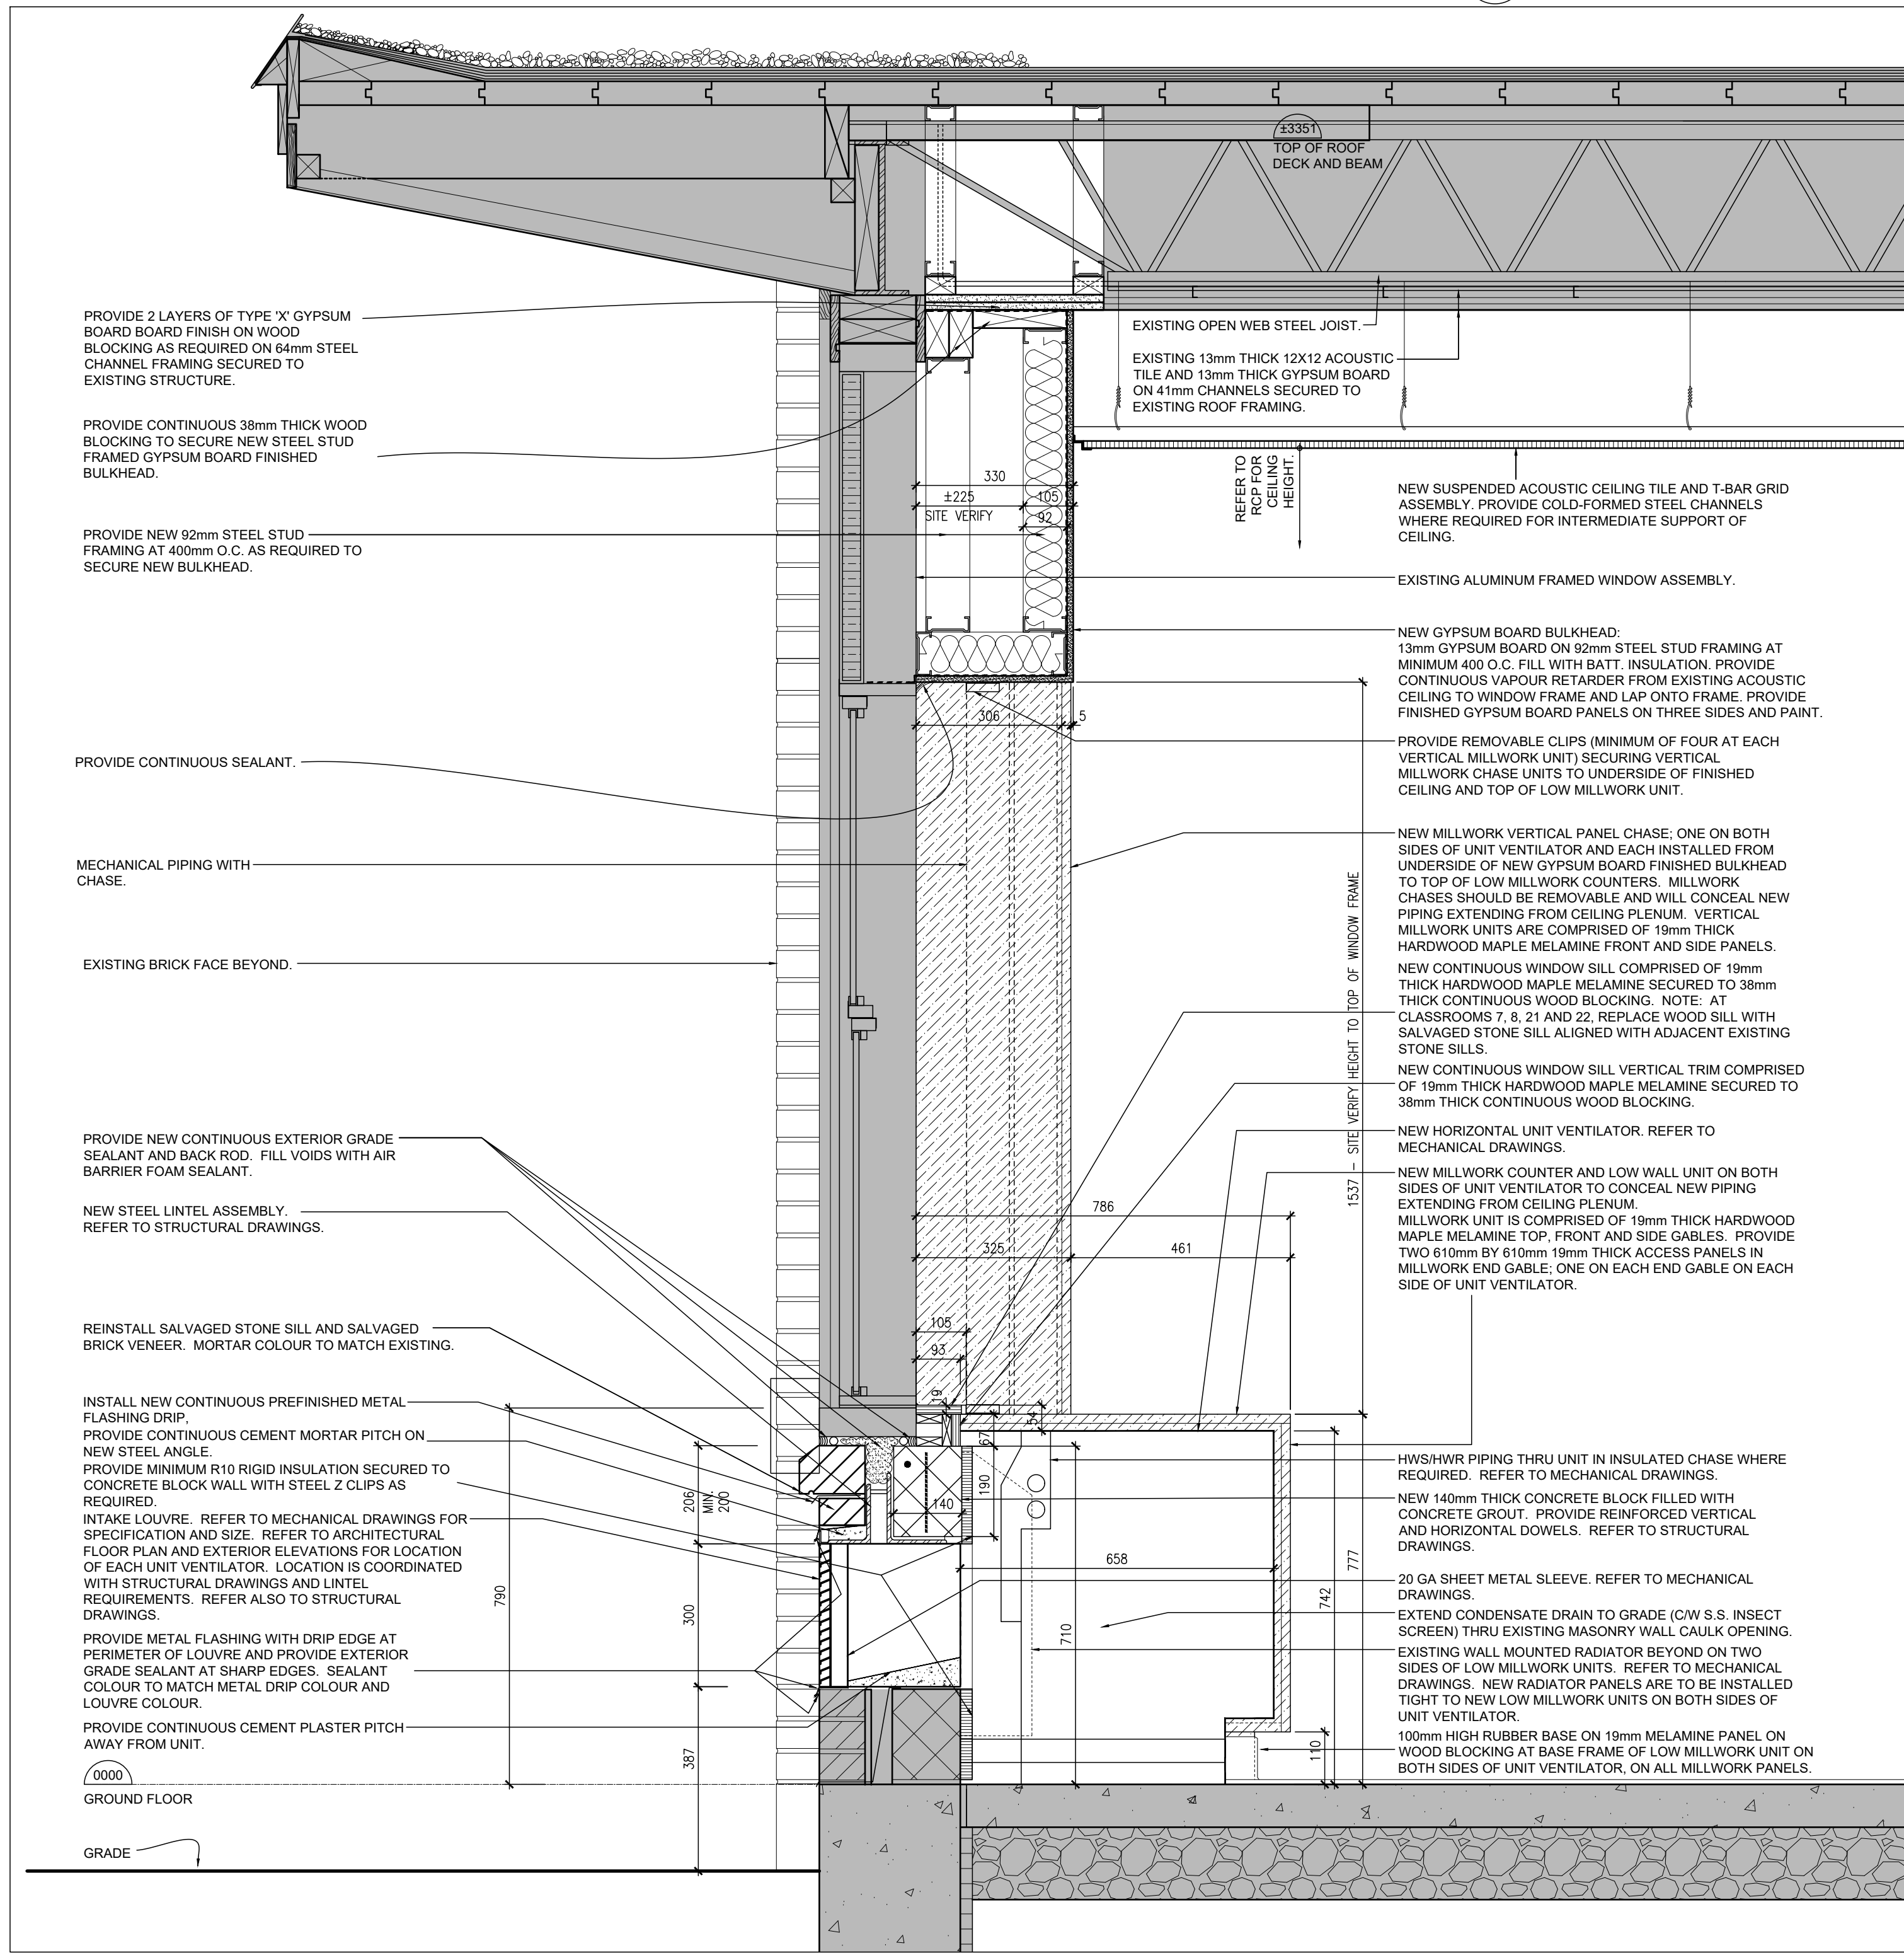

1  
A5.1  
PROPOSED WALL SECTION  
1:10

NOTE: THIS DRAWING IS NOT TO BE SCALED. THE CONTRACTOR IS RESPONSIBLE FOR THE VERIFICATION OF ALL SITE DIMENSIONS AND FOR NOTIFYING THE ARCHITECT OF ANY SITE CONDITIONS AND SITE MEASUREMENTS THAT ARE NOT CONSISTENT WITH THE DRAWINGS.



no.	revision	date

no.	issue	date
1	Issued for Client Review	March 1, 2021
2	Issued for Schematic Design Report	March 15, 2021
3	Issued for Schematic Design Report	March 30, 2021
4	Issued for Permit and Tender	Jan. 28, 2022

project  
WRDSB TAIT STREET PUBLIC SCHOOL HVAC RENOVATIONS  
TENDER No. 7198-RW-22

WATERLOO REGION DISTRICT SCHOOL BOARD  
184 TAIT ST., CAMBRIDGE, ON N1S 3G3

drawing  
drawing scale

AS NOTED

ward99 project number

21008 - TAIT PS

ward99 architects

drawing no.

Wa  
RD<sub>99</sub>

ward99 architects inc.  
7500 Highway 27, Unit 27B  
Vaughan ON L4H 0J2  
info@ward99architects.com  
416 613 5860 www.ward99architects.com

A5.1

